


① MAIN FLOOR PLAN
8736 GROSS SF.

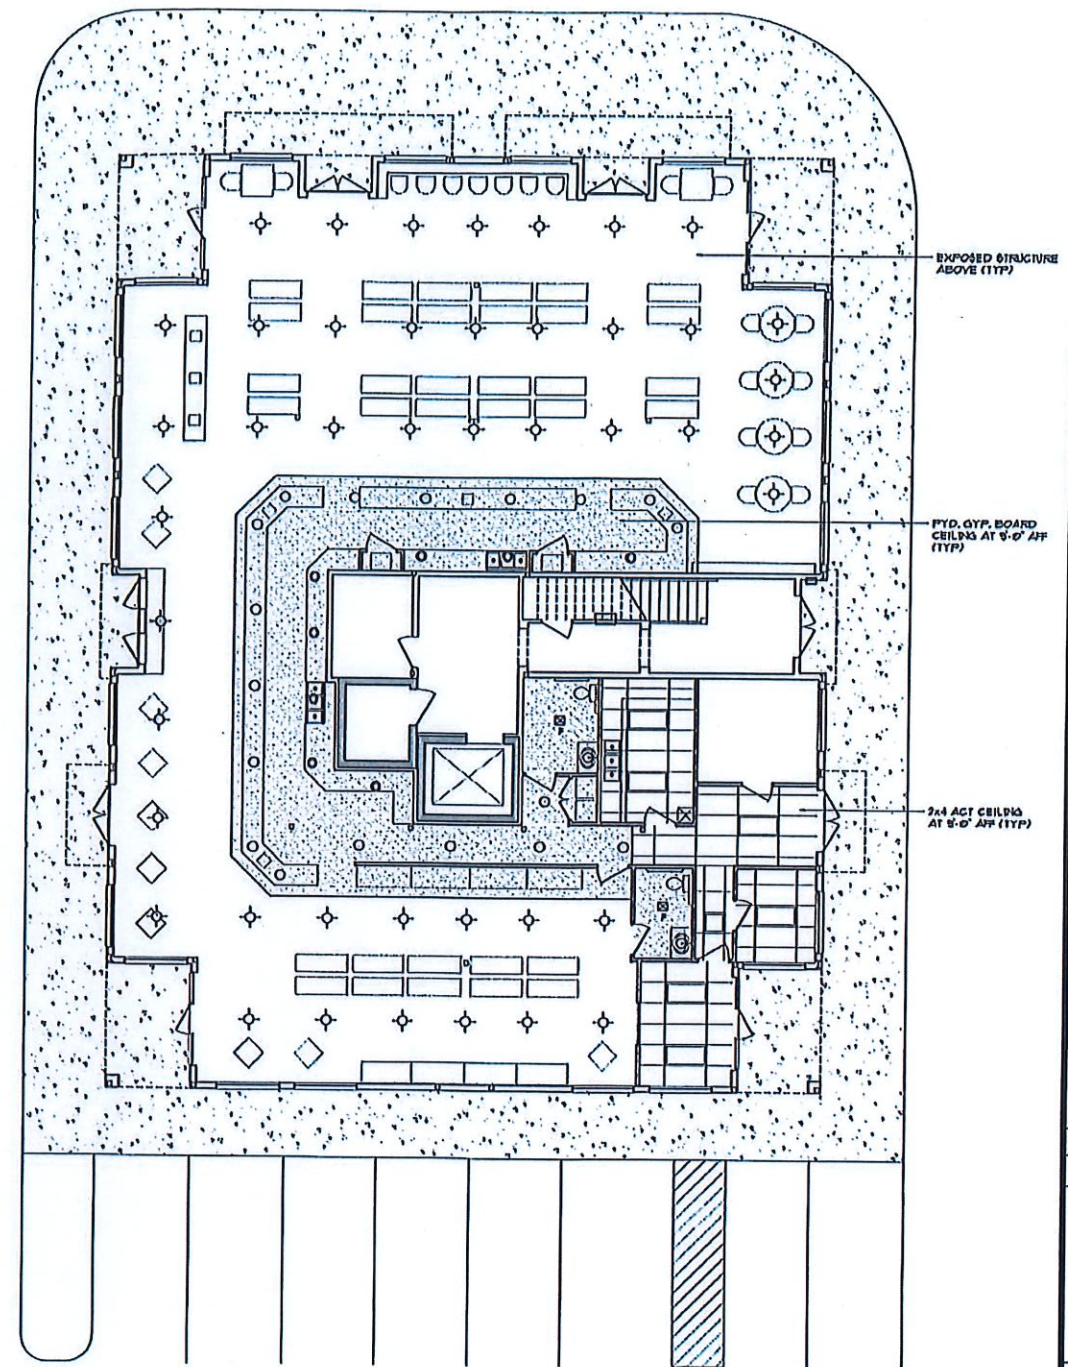

② REFLECTED CEILING PLAN

ELECTRICAL LEGEND	
□	2x4 LED LIGHTING FIXTURE
□	2x4 LED LIGHTING FIXTURE
○	WALL MOUNTED LED FIXTURE
○	LED PENDANT FIXTURE
○	LED RECESSED WALL-WASHER CAN LIGHT
○	LED RECESSED CAN LIGHT
○	GENERAL PURPOSE DUPLEX RECEPTACLE
○	220V OUTLET
○	60V OUTLET
⤴	TELEPHONE AND/OR DATA
⊠	EXHAUST FAN

dBF
Associates
Architects

P.O. Box 78
Charlottesville, VA 22902
(434) 977-2791
(434) 977-0593 (FAX)

**HARWICH PORT COMMONS -
FARMER'S MARKET**
HARWICH, MASSACHUSETTS

NO	DESCRIPTION	DATE
REVISIONS		
FLOOR PLANS		
SCALE 1/8" = 1'-0"		
DATE 11-18-19		
DWN BY JDB		
CHECKED BY RJFJR		
PROJECT NO V1925		
DRAWING NO A1		
OF		1