



1 MAIN FLOOR PLAN
 0736 GROCERY SF.

SEATING SUMMARY	
LOCATION	# OF SEATS
INDOOR TABLES	17
INDOOR BAR	8
BAR RAIL	5
OUTDOOR TABLES	28
TOTAL	58

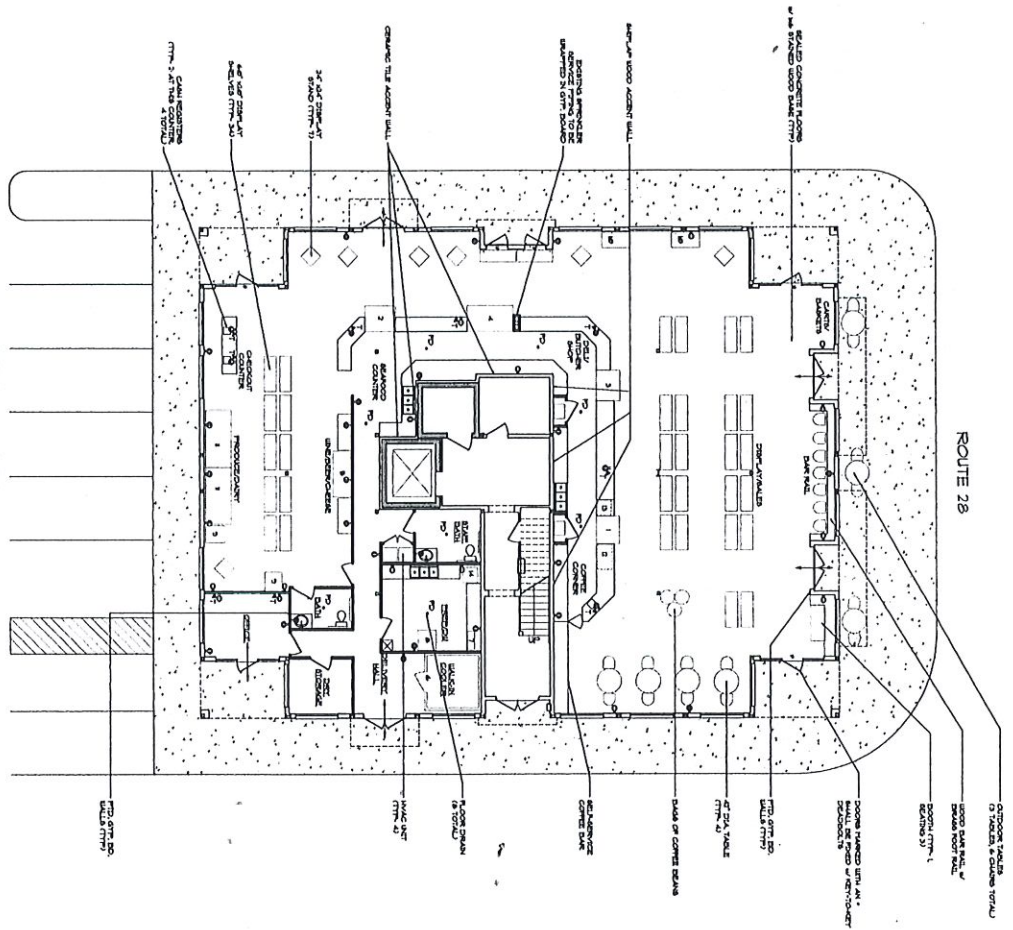

1 MAIN FLOOR PLAN
SCALE: AS SHOWN

NO.	DESCRIPTION	DATE
1	CONTRACTOR	
2	OWNER	
3	ARCHITECT	
4	ENGINEER	
5	INSPECTOR	
6	PERMITS	
7	CONSTRUCTION	
8	COMPLETION	
9	AS-BUILT	
10	REVISIONS	
11	NOTES	
12	GENERAL NOTES	
13	SECTION NOTES	
14	DETAIL NOTES	
15	FINISHES	
16	MECHANICAL	
17	ELECTRICAL	
18	PLUMBING	
19	HEATING & COOLING	
20	SAFETY	
21	ACCESSIBILITY	
22	ENVIRONMENTAL	
23	OTHER	

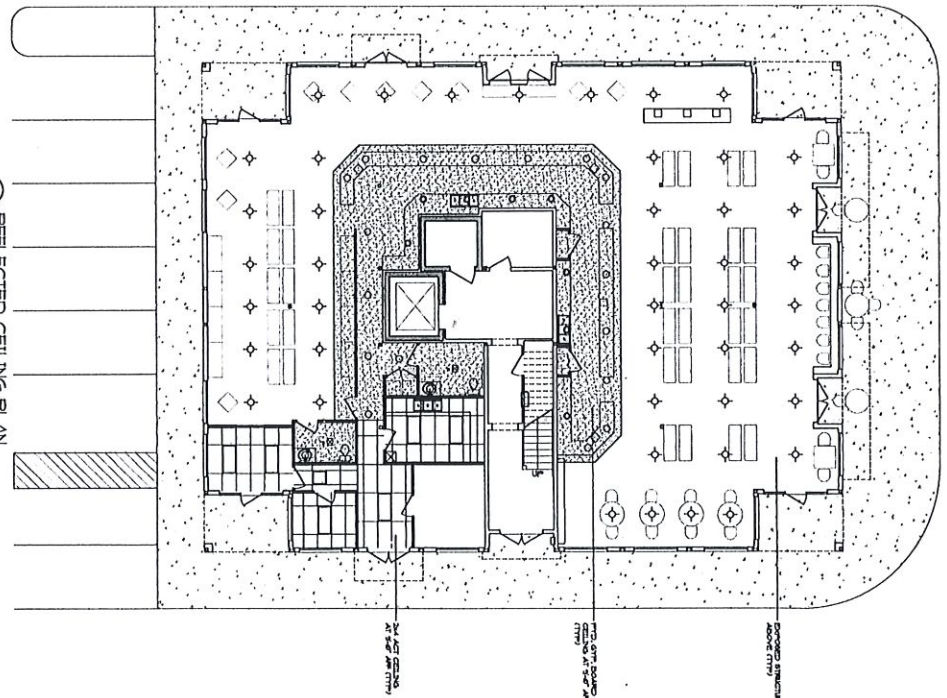

2 REFLECTED CEILING PLAN
SCALE: AS SHOWN

NO.	DESCRIPTION	DATE
1	CONTRACTOR	
2	OWNER	
3	ARCHITECT	
4	ENGINEER	
5	INSPECTOR	
6	PERMITS	
7	CONSTRUCTION	
8	COMPLETION	
9	AS-BUILT	
10	REVISIONS	
11	NOTES	
12	GENERAL NOTES	
13	SECTION NOTES	
14	DETAIL NOTES	
15	FINISHES	
16	MECHANICAL	
17	ELECTRICAL	
18	PLUMBING	
19	HEATING & COOLING	
20	SAFETY	
21	ACCESSIBILITY	
22	ENVIRONMENTAL	
23	OTHER	

ELECTRICAL LEGEND	
○	3/4" LIGHT BULB
○	1/2" LIGHT BULB
○	1" LIGHT BULB
○	2" LIGHT BULB
○	4" LIGHT BULB
○	6" LIGHT BULB
○	8" LIGHT BULB
○	10" LIGHT BULB
○	12" LIGHT BULB
○	14" LIGHT BULB
○	16" LIGHT BULB
○	18" LIGHT BULB
○	20" LIGHT BULB
○	22" LIGHT BULB
○	24" LIGHT BULB
○	26" LIGHT BULB
○	28" LIGHT BULB
○	30" LIGHT BULB
○	32" LIGHT BULB
○	34" LIGHT BULB
○	36" LIGHT BULB
○	38" LIGHT BULB
○	40" LIGHT BULB
○	42" LIGHT BULB
○	44" LIGHT BULB
○	46" LIGHT BULB
○	48" LIGHT BULB
○	50" LIGHT BULB
○	52" LIGHT BULB
○	54" LIGHT BULB
○	56" LIGHT BULB
○	58" LIGHT BULB
○	60" LIGHT BULB
○	62" LIGHT BULB
○	64" LIGHT BULB
○	66" LIGHT BULB
○	68" LIGHT BULB
○	70" LIGHT BULB
○	72" LIGHT BULB
○	74" LIGHT BULB
○	76" LIGHT BULB
○	78" LIGHT BULB
○	80" LIGHT BULB
○	82" LIGHT BULB
○	84" LIGHT BULB
○	86" LIGHT BULB
○	88" LIGHT BULB
○	90" LIGHT BULB
○	92" LIGHT BULB
○	94" LIGHT BULB
○	96" LIGHT BULB
○	98" LIGHT BULB
○	100" LIGHT BULB

DBF Associates Architects

P.O. Box 78
Charlottesville, VA 22902
(434) 977-2391
(434) 977-2333 (FAX)

**HARWICH PORT COMMONS-
FARMER'S MARKET**

HARWICH, MASSACHUSETTS

NO. DISCREPANCY DATE

REVISIONS

FLOOR PLANS

SCALE
1/8" = 1'-0"

DATE
1-10-20


DRAWN BY
JCB

CHECKED BY
R.F.R.

PROJECT NO.
V1925

DRAWING NO.
A1

OF 1

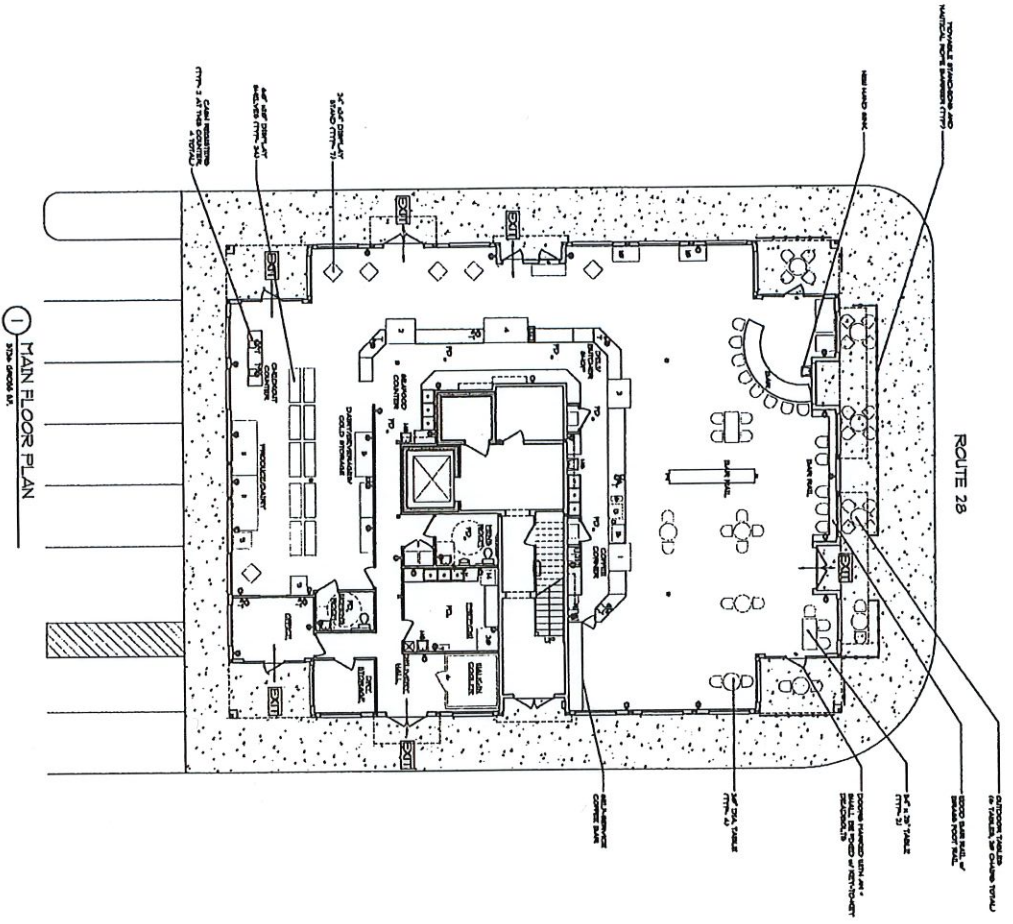

① MAIN FLOOR PLAN
3/28/88

NO.	DATE	DESCRIPTION
1	3/28/88	ISSUED FOR PERMIT
2		
3		
4		
5		
6		
7		
8		
9		
10		

<p>DBF Associates Architects</p> <p>P.O. Box 78 Cheritonville, VA 22902 (404) 977-2781 (404) 977-0513 (FAX)</p>	<p>CAPE ROOTS HARWICH, MASSACHUSETTS</p>
	<p>NO. / REVISION / DATE</p> <p>FLOOR PLAN - SEATING TOTALS</p> <p>SCALE: 1/8" = 1'-0"</p> <p>DATE: 3-16-88</p> <p>DRAWN BY: ASB</p> <p>CHECKED BY: R.F.R.</p> <p>PROJECT NO: V2118</p> <p>DRAWING NO: A1</p>